


OBSIDIAN GROUP INC.
1770 ARGENTIA ROAD
MISSISSAUGA, ONTARIO
L5N 3S7

PROJECT:
20 MAIN ST., GRAND BEND

DWG. TITLE:
MAIN FLOOR PLAN, UNIT 2 & 3

Reviewed and Approved
as marked

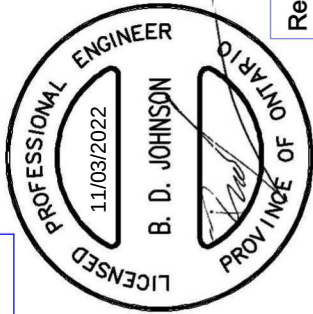

Johnson Engineering Consultants
368 Huron Street
Stratford, Ontario N5A 5T5

NOTES:
ALL WA
RESIST,
- 38mm
- 89mm
- RESILI
- 1 LAYE
- 2 LAYE


NOTES:

ALL WALLS BETWEEN SUITES, SUITES AND EXIT CORRIDORS ARE TO HAVE A FIRE RESISTANCE RATING OF 1 HOUR AND A STC RATING OF 50 OR HIGHER AS PER SB-3 W50:

- 38mm x 89mm WOOD STUDS @ 610mm o.c.
- 89mm THICK ABSORPTIVE MATERIAL
- RESILIENT METAL CHANNELS ON ONE SIDE SPACED@ 610mm o.c.
- 1 LAYER OF 15.9mm TYPE X GYPSUM BOARD ON RESILIENT METAL CHANNEL SIDE
- 2 LAYERS OF 15.9mm TYPE X GYPSUM ON OTHER SIDE

NOTES Cont'd.:
ALL DOORS TO BE 38"x80" METAL DOORS WITH 45 MIN. FIRE RESISTANCE RATING AND BE EQUIPTED WITH A SELF CLOSING DEVICE.

BLOCKING IS TO BE PROVIDED IN ALL WASHROOMS

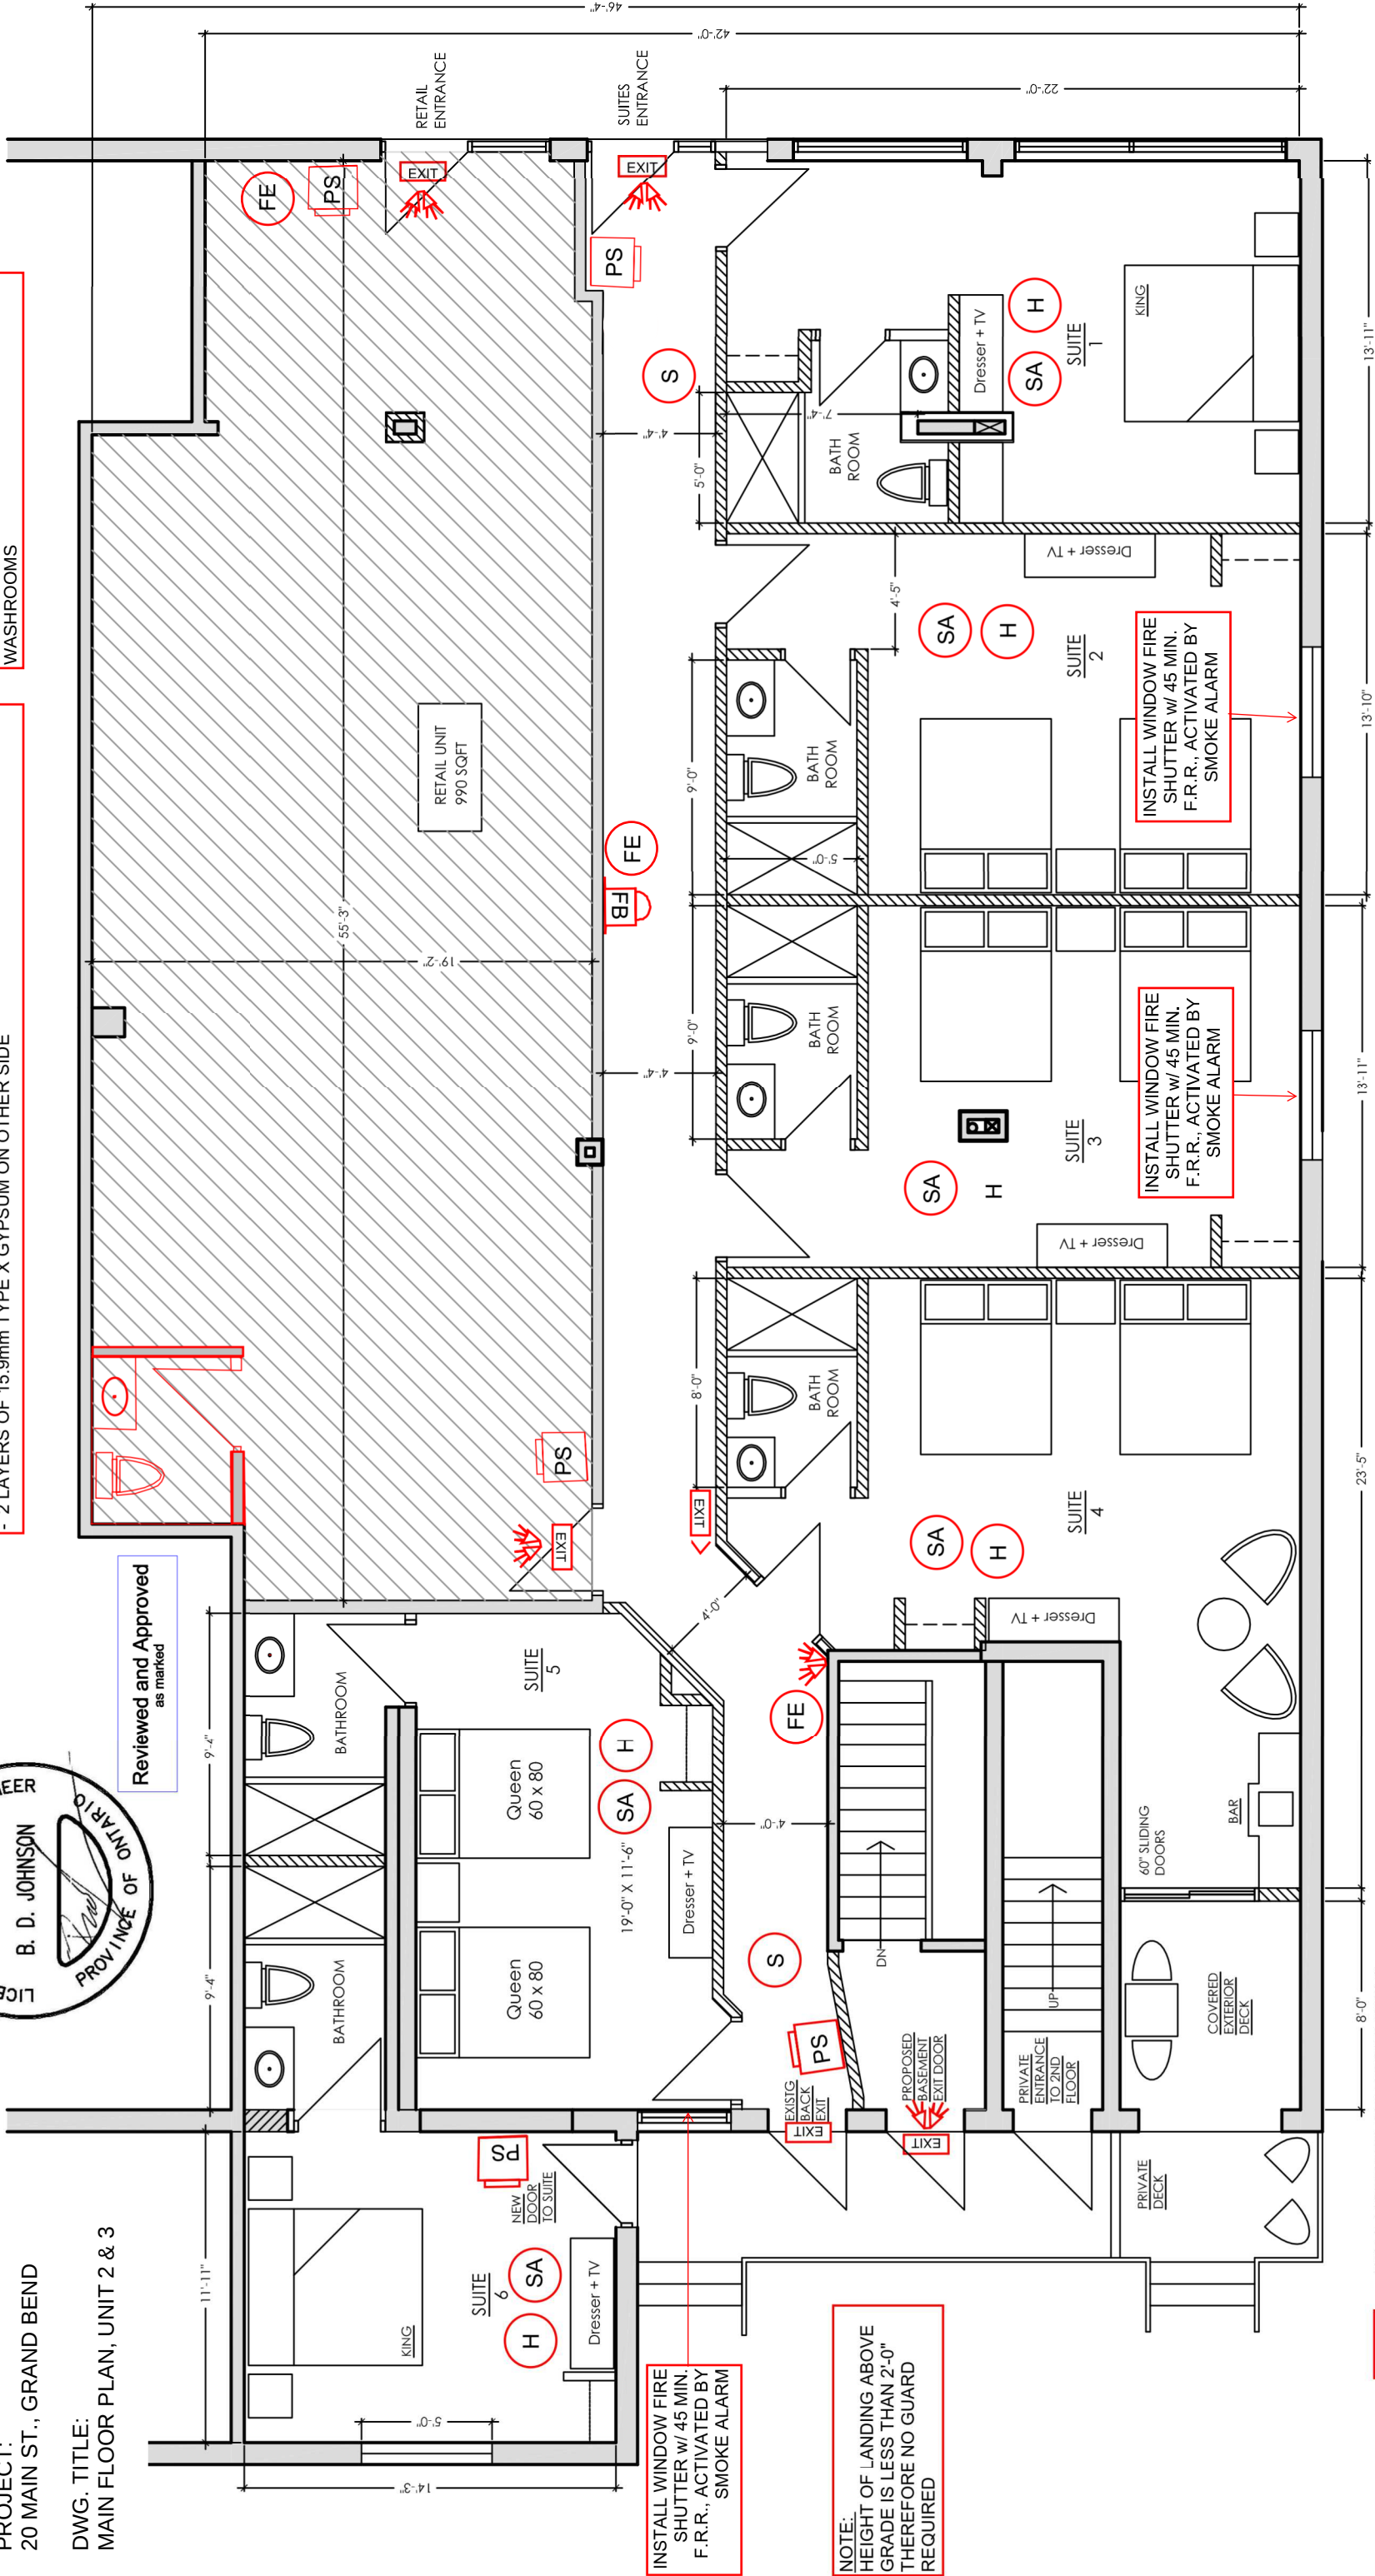

EXIT

EXIT

WALL MOUNTED SELF POWERED 2
WATTLED RUNNING MAN EXIT SIGN

2 WATT L.E.D. RUNNING MAN EXIT SIGN

REMOTE EMERGENCY LIGHT HEADS C/W 5 WATT, 12 VOLT,
DOUBLE HEAD TO BE WALL AND/OR CEILING MOUNTED AS
INDICATED - STANDPRO MODEL: M2-12V-5WLA-WH (WHITE)
(WIRED TO BATTERY SPECIFIED

S SMOKE DETECTOR

SA SMOKE ALARM (CONNECTED TO FIRE ALARM)

H HEAT DETECTOR (CONNECTED TO FIRE ALARM)

EB FIRE ALARM BELL/ SIREN & STROB

PULL STATION

FE FIRE EXTINGUISHER